 
 
 



**Key**

-  2kW Fresnel
-  1.2kW Fresnel
-  1kW Profile
- ID number
- Lee gel reference

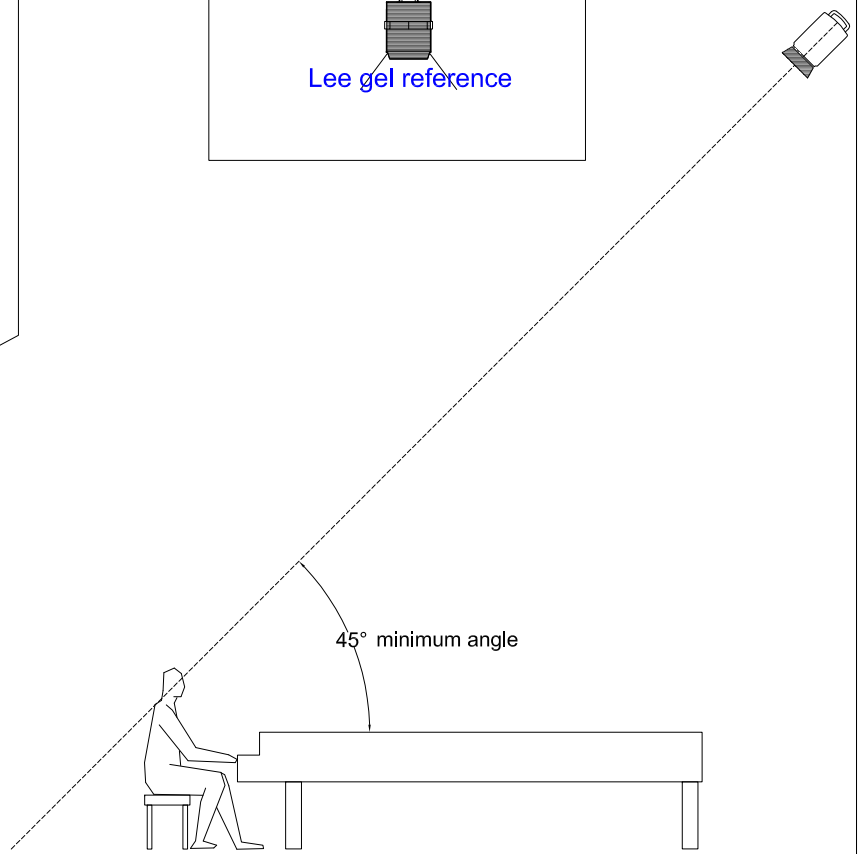

# Sydney International Piano Competition

## Generic Lighting Plan

Scale NTS  
 Date Feb 2020  
 Drawn by Roderick van Gelder  
 Version 1



Drawing provided for general information only.  
 Do not scale of drawing or print  
 All dimensions to be checked on-site  
 © Roderick van Gelder  
 NOTE: All design concepts and principles remain  
 Intellectual Property of Roderick van Gelder.  
 Do not copy or distribute these plans without written  
 permission from Roderick van Gelder.